

THIS DRAWING IS THE PROPERTY OF PPL ELECTRIC UTILITIES AND CONTAINS PROPRIETARY AND CONFIDENTIAL INFORMATION WHICH MUST NOT BE DUPLICATED, USED OR DISCLOSED WITHOUT WRITTEN AUTHORIZATION FROM PPL ELECTRIC UTILITIES.


CERTIFIED CORRECT PLANS

William A. P.E.
Professional Engineer
Approved by Bureau of Technical Utility Services

PA PUBLIC UTILITY COMMISSION


ATTEST *Rebecca Chiverton*
Secretary

01/11/2024
Docket: A-2023-3042387

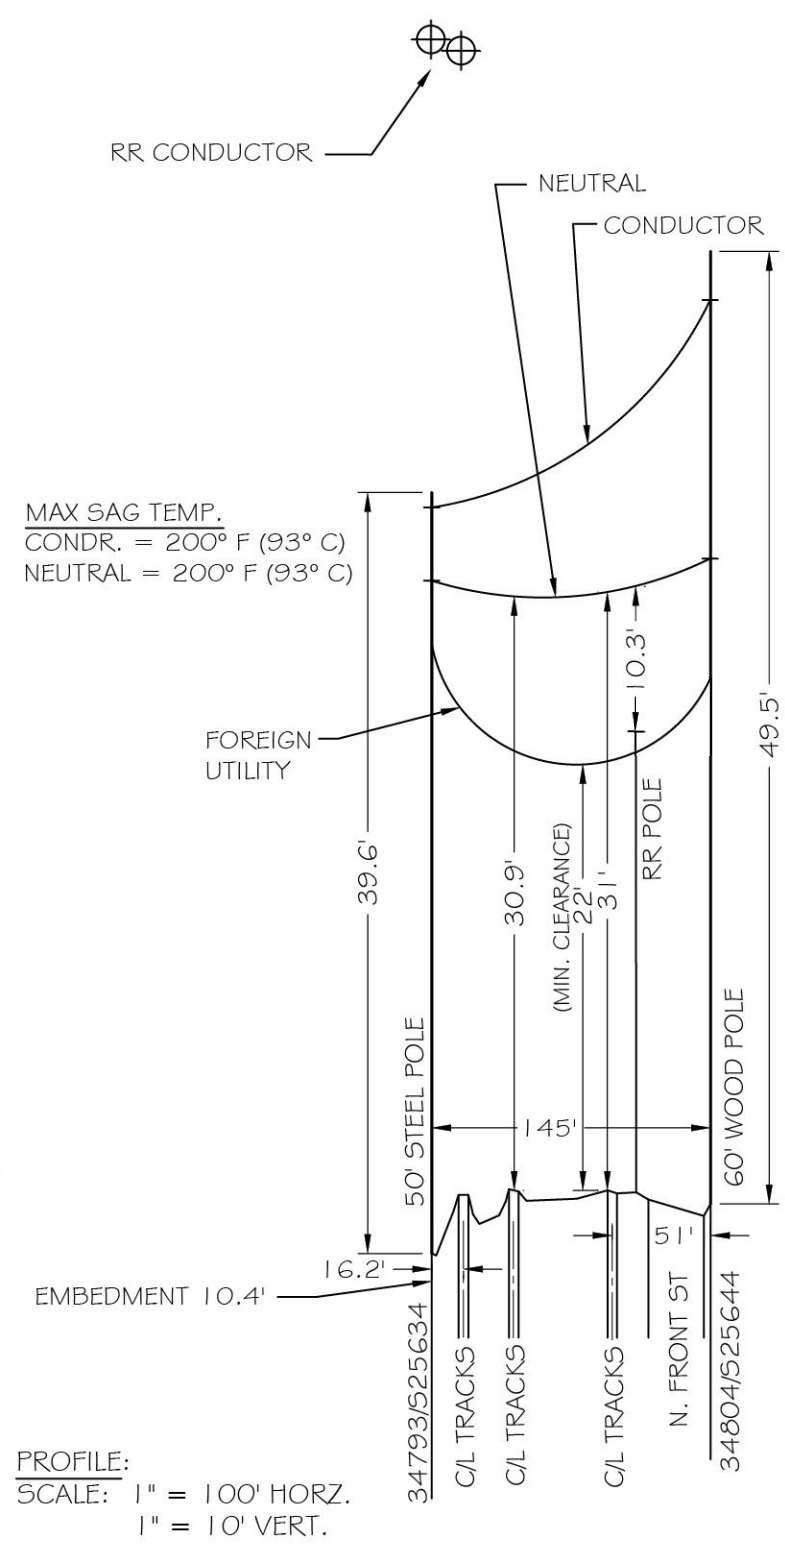

PROFILE:
SCALE: 1" = 100' HORZ.
1" = 10' VERT.

NOTE:
CONTRACTORS SHALL FOLLOW ALL REQUIREMENTS OF NORFOLK SOUTHERN'S NSCE-4 AND NSCE-8 SPECIFICATIONS.

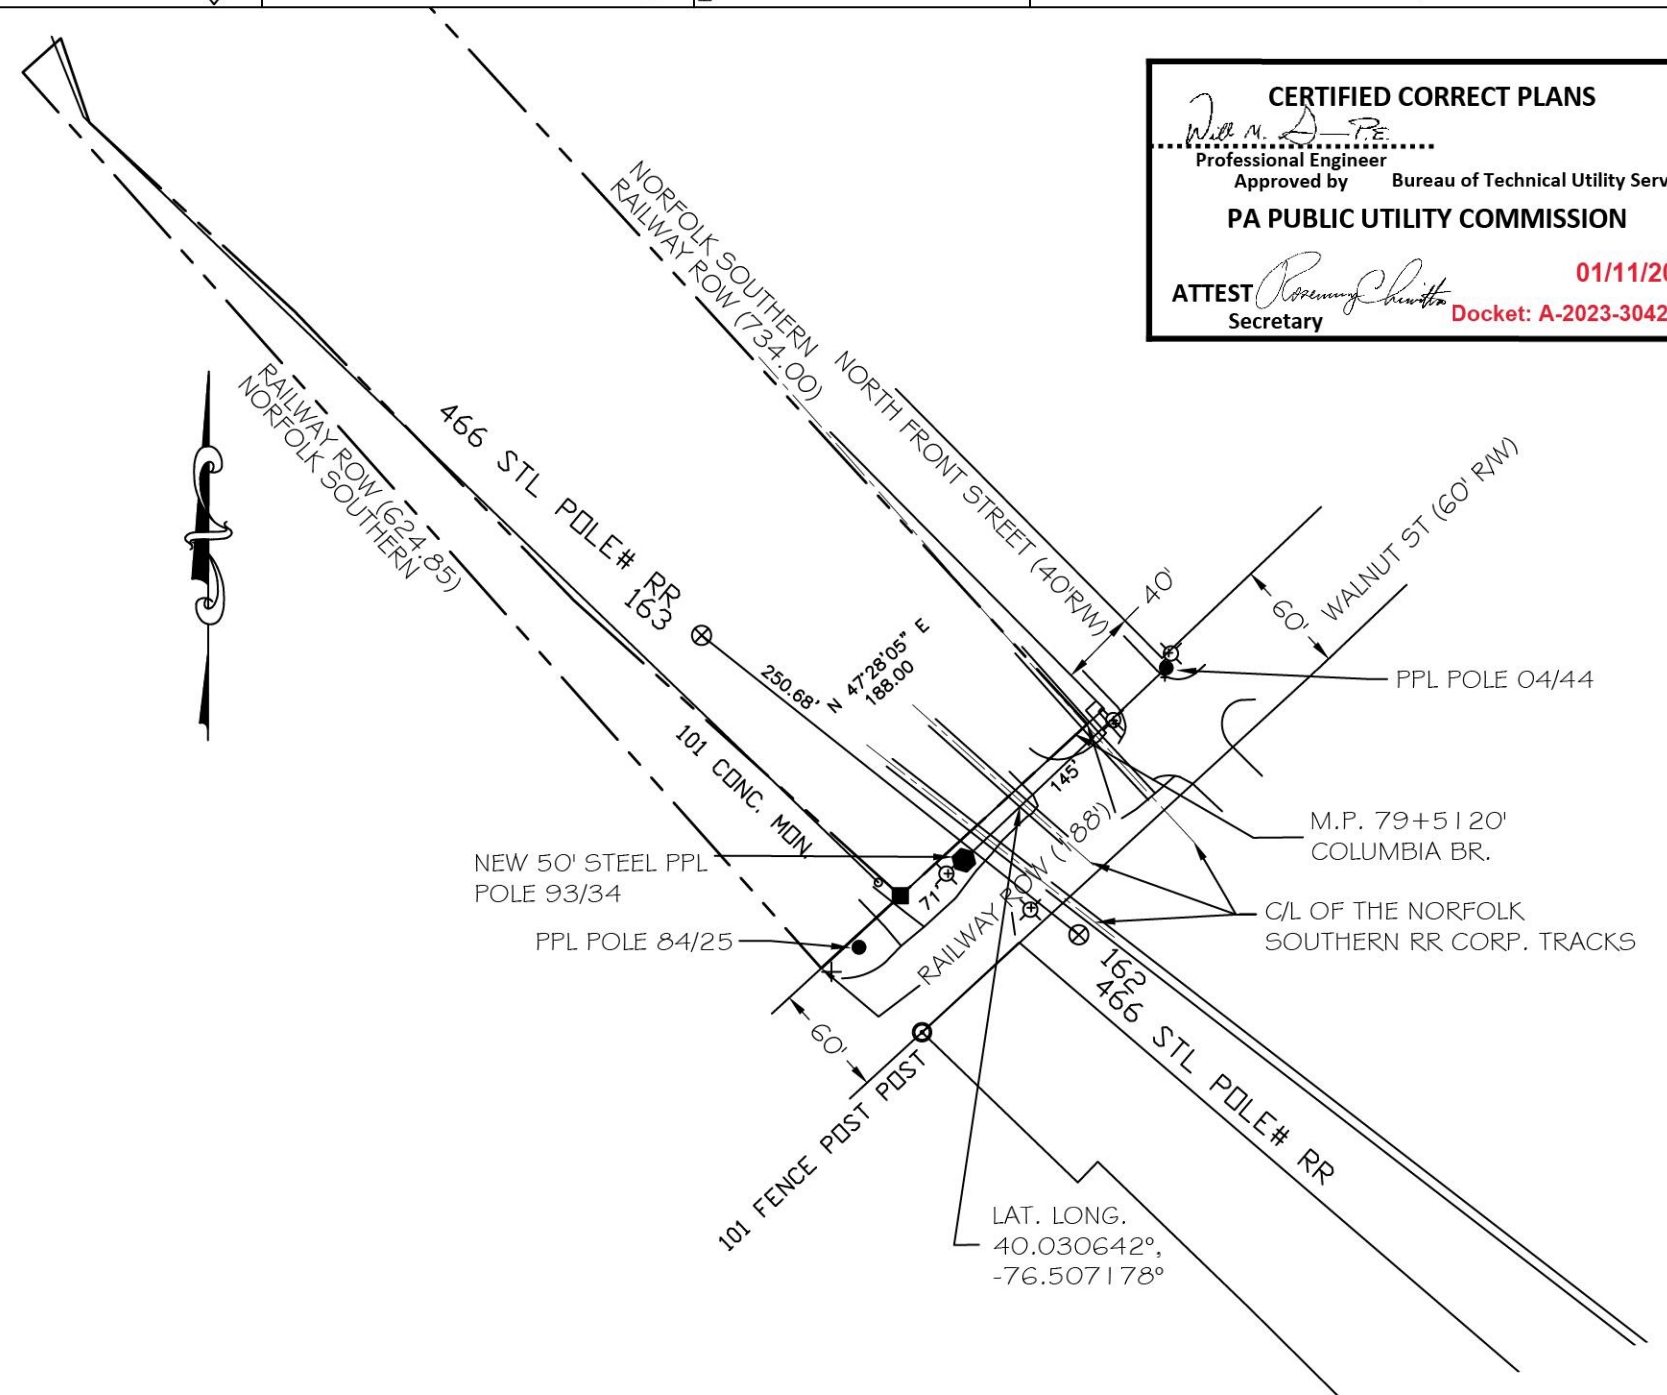

PLAN :
SCALE: 1" = 100'



ACCT- 141818	PLAN AND PROFILE OF 06-02 LINE CROSSING		
SCALE- AS SHOWN	NORFOLK SOUTHERN RR CO. TRACKS		
BY- LFH	AT FRONT AND WALNUT STREETS		
	LAT. 40.030642°, LONG. -76.507178°		
	BORO OF COLUMBIA	LANCASTER CO., PA	
APPROVED	J.A. SIEGFRIED	DATE 7-16-52	PPL ELECTRIC UTILITIES
REVIEWED		PPL DRAWING NO. LB39945	SHEET NO. 1
			REV. 3

NO.	DATE	ACCT.	REVISION	BY	REVIEWED	APPROVED	CAD ID
3	10/2023	12945663	REPLACED WOOD POLE 93/34 WITH 50' STEEL POLE	JJA	CAM	RAG	
2	8-15-13	250817	SHOW RR CONDUCTOR AND DISTANCE.	JJA	RJD	ESN	
1	5-13	250817	REVISED X-ING FOR NEW POLES AND OWNER.	JJA	RJD	RJD	

PPL ELECTRIC UTILITIES (8/01)

PC CAD

LC09							
LOCATION CODES	PLAN & PROFILE	FACILITY MAP					